

Bank of America Vienna ELP

235 Maple Ave W
Vienna, VA 22180

SERIAL NUMBER:
NRSP VERSION:
BULLETIN:




420 North Harbor Drive, Suite 101, Arlington, VA 22201
T: 703.906.4501 F: 703.906.4502
www.littleonline.com

This drawing and the design ideas are the property of Little Diversified Architectural Consulting. The reproduction, copying or other use of this drawing without their written consent is prohibited and any infringement will be subject to legal action.
© Little 2019

| Issue | Date & Issue Description | By | Check |
|-------|----------------------------------|----|-------|
| 01 | 01/23/2019 OWNER'S SUBMISSION | | |
| 02 | 02/28/2019 PERMIT SUBMISSION | | |

GENERAL NOTES:

- A. SEE SHEET E0.01 FOR PROJECT DETAILS, SCHEDULES AND SPECIFICATIONS. ALL NOTES ON SHEET E0.01 SHALL APPLY TO THIS DRAWING.
- B. SEE LIGHTING FIXTURE SCHEDULE FOR FIXTURE MOUNTING HEIGHTS.
- C. ELECTRICAL PLANS ARE DIAGRAMMATIC. DO NOT SCALE DRAWINGS EXCEPT WHERE DIMENSIONS ARE SHOWN.

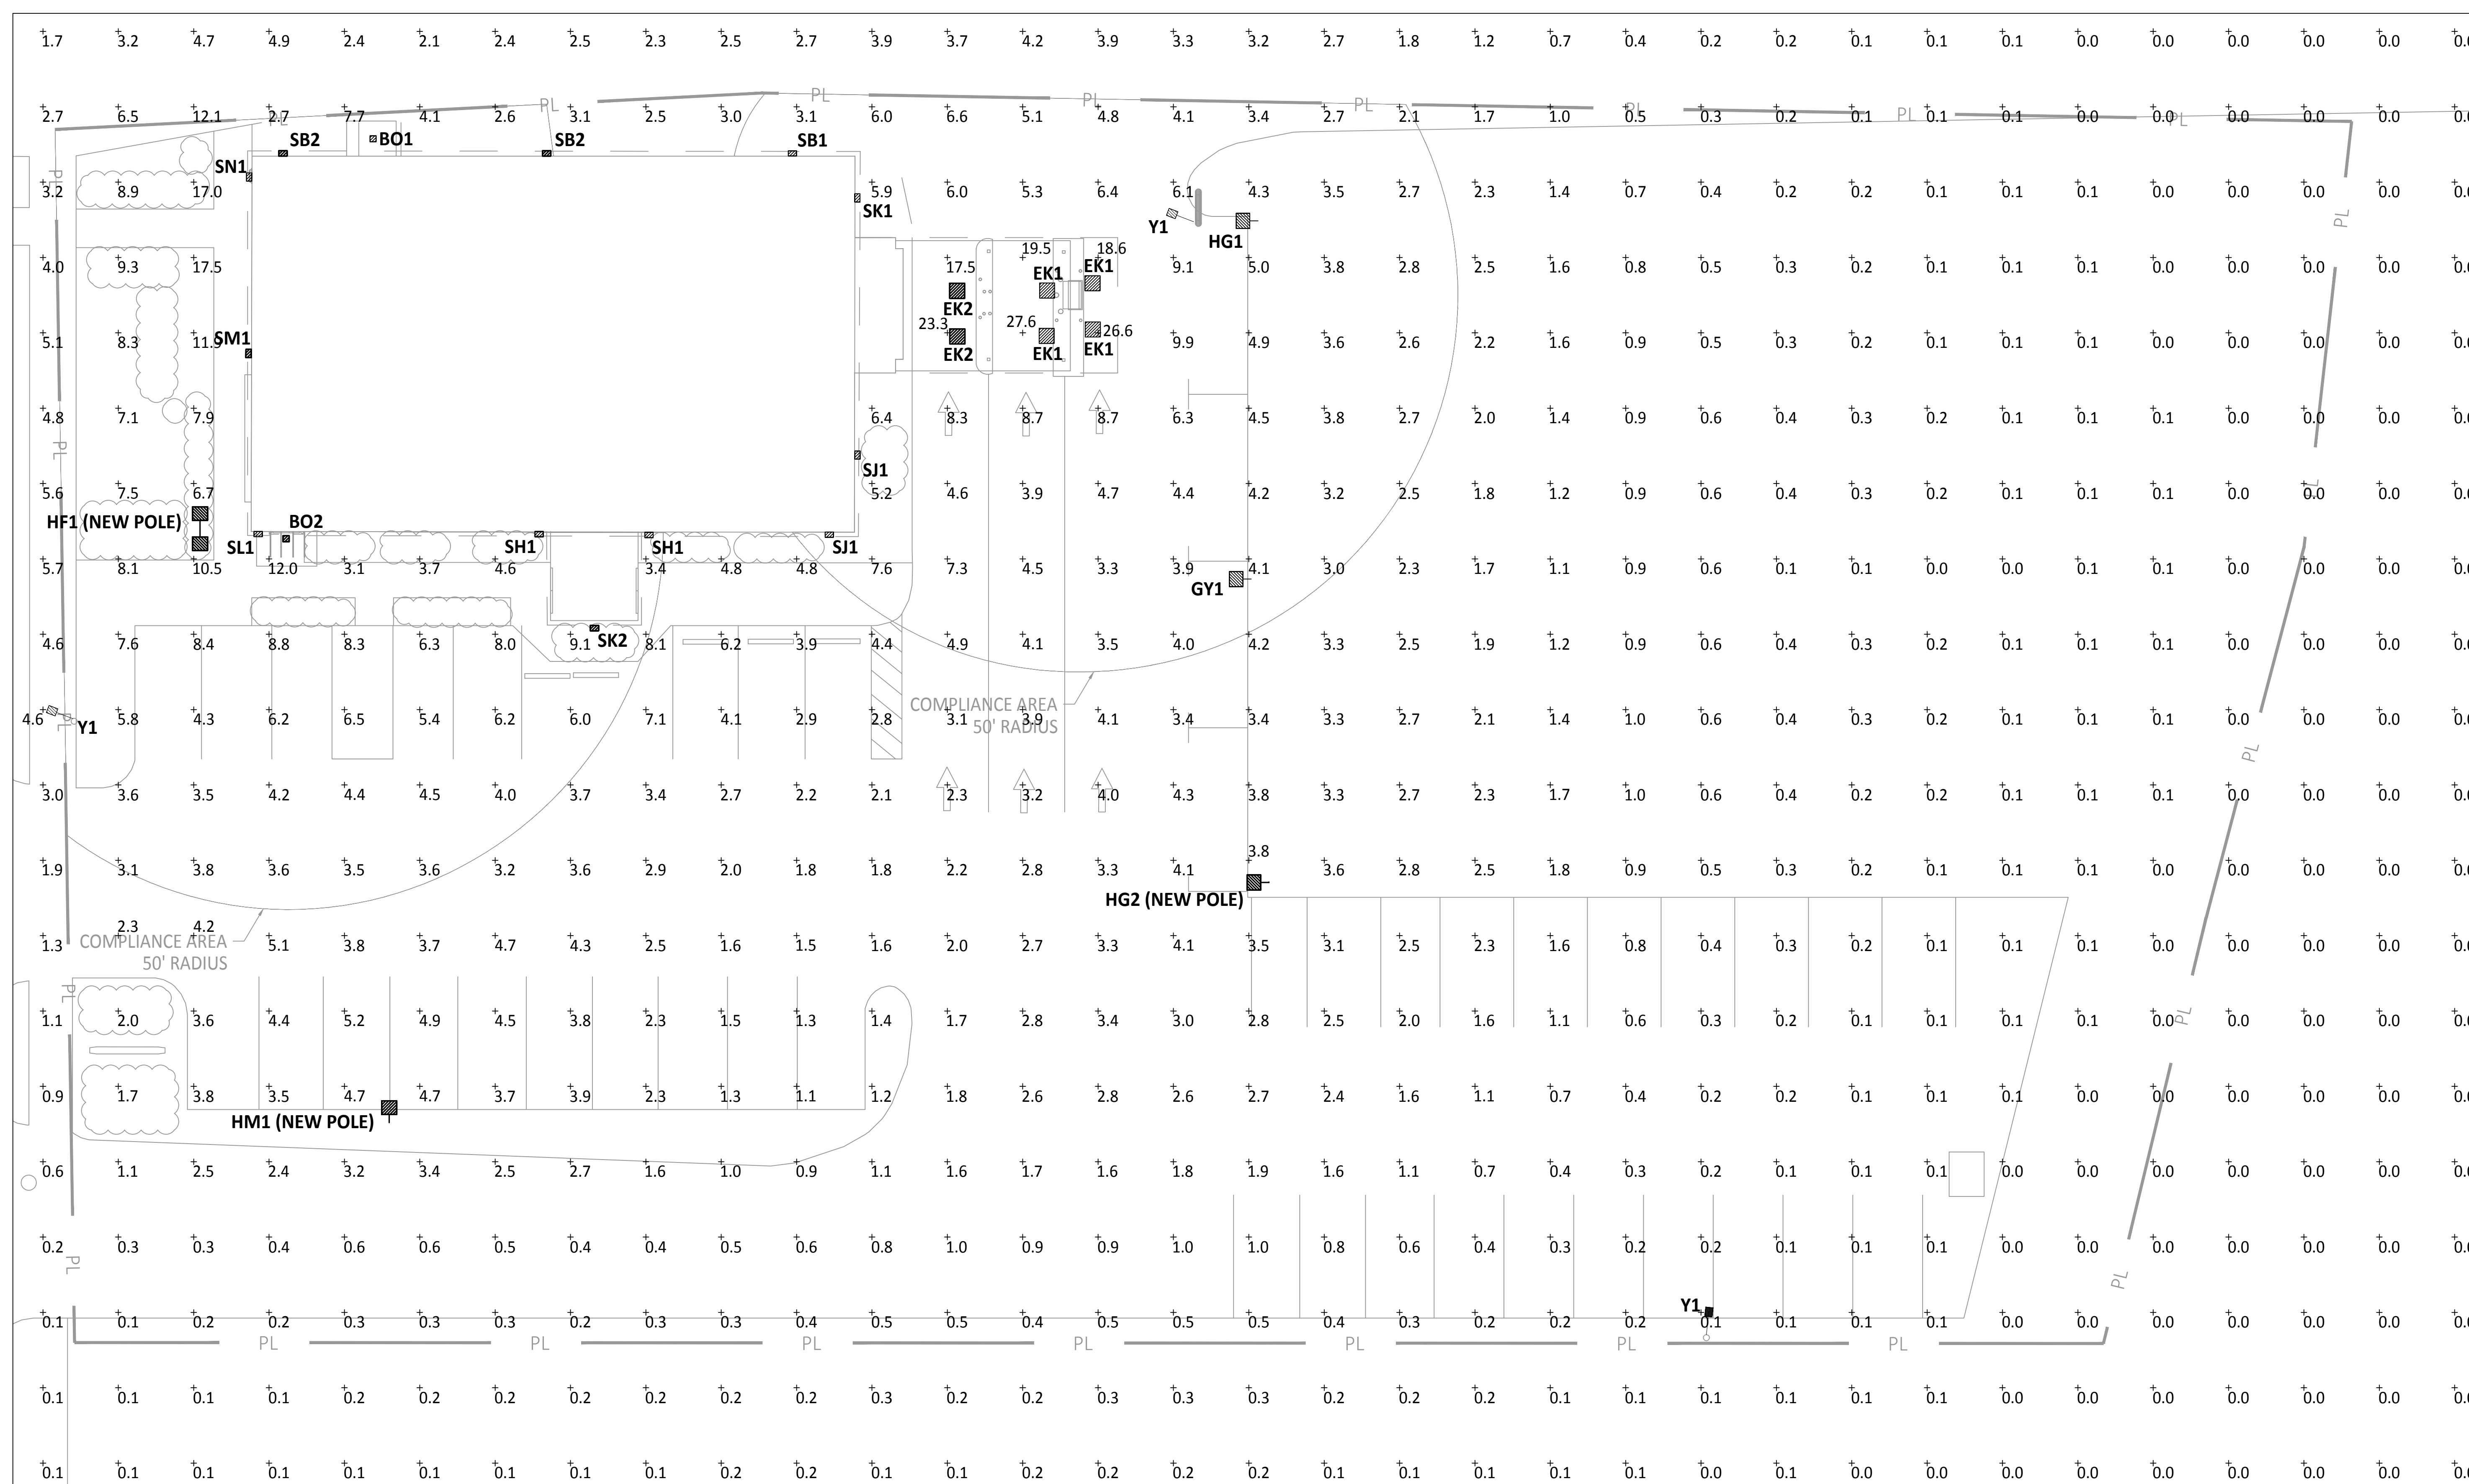

1 PHOTOMETRIC PLAN
E3.01 3/32" = 1'-0"

SITE LIGHTING DESIGN STATEMENT

THE INDICATED BUILDING-MOUNTED AND POLE-MOUNTED LIGHTING DESIGN, INCLUDING FIXTURE SELECTIONS, INSTALLATION LOCATIONS AND SUPPORTING PHOTOMETRIC CALCULATIONS, HAS BEEN PERFORMED BY THE OWNER'S CONSULTANT (GMR). THE BUILDING-MOUNTED AND POLE-MOUNTED FIXTURES, INCLUDING FIXTURE SUPPORTS, POLE BASES AND ALL INDICATED CIRCUITING, ARE INCLUDED IN THE CONTRACT AND SHALL BE PROVIDED AND INSTALLED BY THE CONTRACTOR, ACCORDING TO THE POLE AND FIXTURE MANUFACTURER'S INSTRUCTIONS.

 
Seal/Signature

Project Name
BANK OF AMERICA - Vienna ELP

PROTOTYPE LAYOUT
223.12125.00
CAD File Name

Description
PHOTOMETRIC PLAN

Scale
3/32" = 1'-0"



E3.01

