


17/20/2019 10:35:59 AM
C:\PROJECTS\2019\2019-01-01\NFCU HQ ADA ELECTRIC VEHICLE CHARGING\01 ELECTRICAL SITE PLAN.DWG

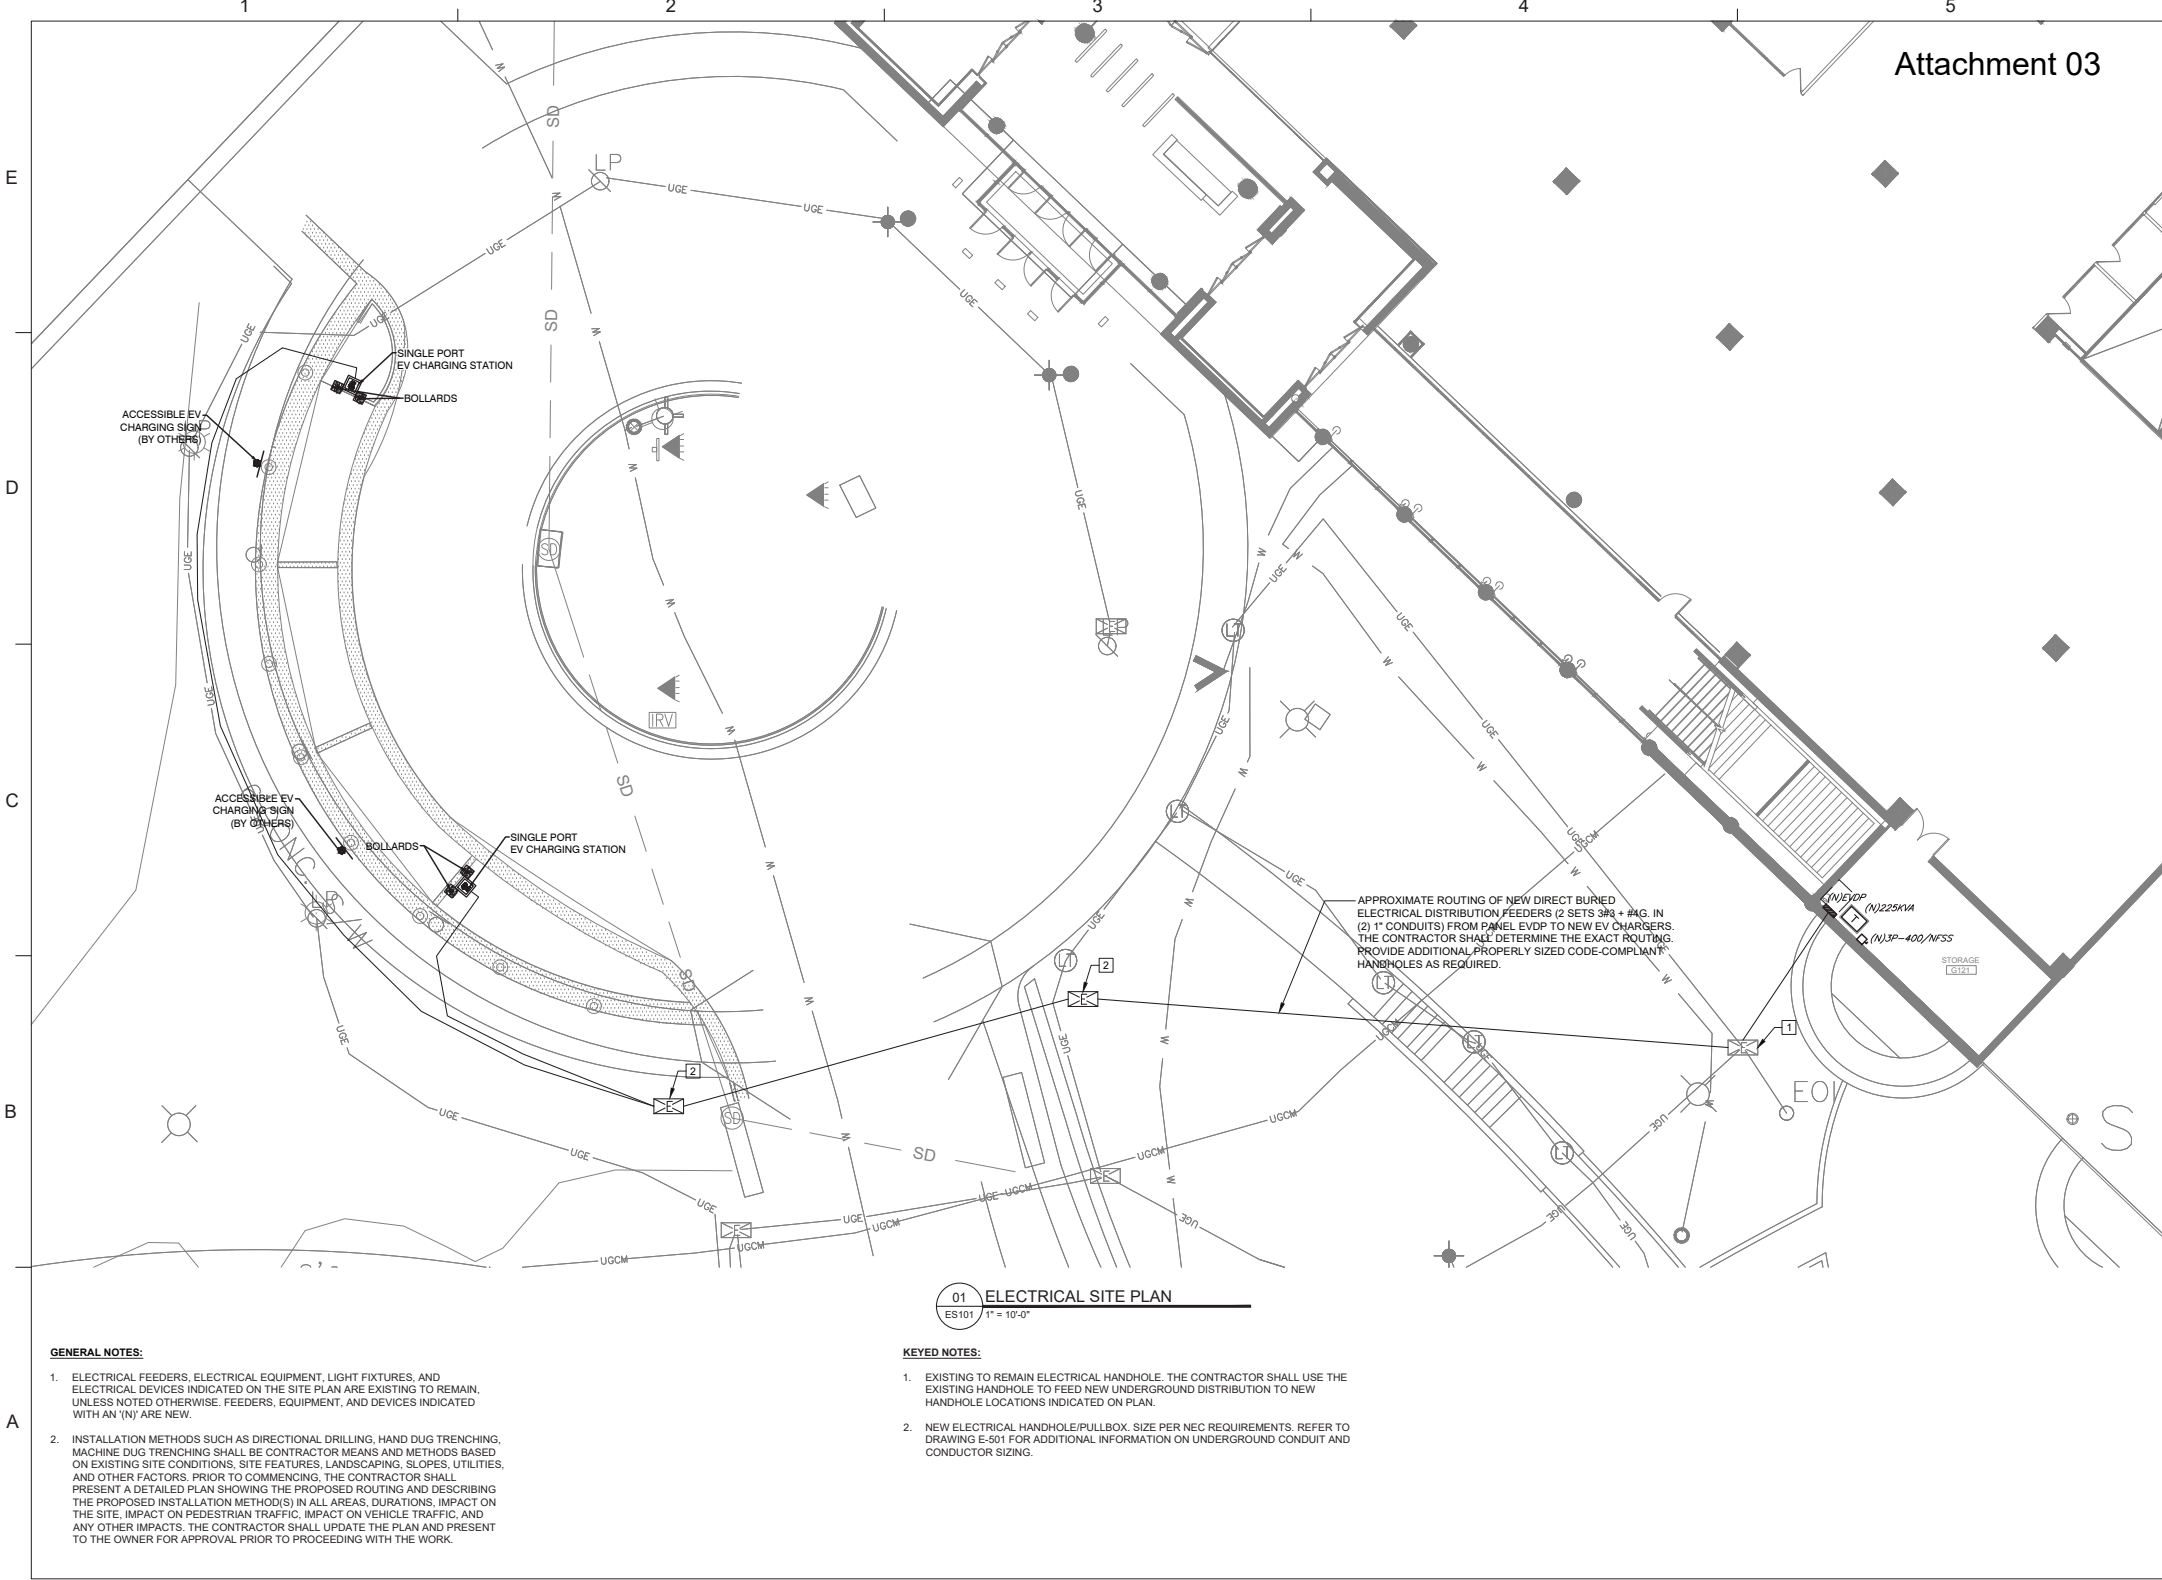

Attachment 03



Dewberry Engineers Inc.
8401 Arlington Blvd.
Fairfax, VA 22031
703.840.0100

FAIRFAX COUNTY, VA
NFCU HQ1 ADA ELECTRIC
VEHICLE CHARGING

 
820 FOLLIN LN SE
VIENNA, VA 22180

ISSUE FOR PERMIT & BID

SEAL



SCALE



REVISIONS

NO.	DESCRIPTION	DATE

B	ISSUE FOR PERMIT & BID	05/29/26
A	OWNER REVIEW	04/07/26

DRAWN BY P.HISHTA

APPROVED BY R.HOLDENER

CHECKED BY R.HOLDENER

DATE 05/29/2026

TITLE
ELECTRICAL SITE
PLAN

PROJECT NO. 50192242

ES101