



CADENCE AT PARK
VIENNA, VIRGINIA

20.014

REVISIONS








DATE	DESCRIPTION
02.08.21	 PERMIT REVISION

FOR PERMIT
01.21.21

TYPICAL UNIT FLOOR PLANS

SHEET NO.

A110

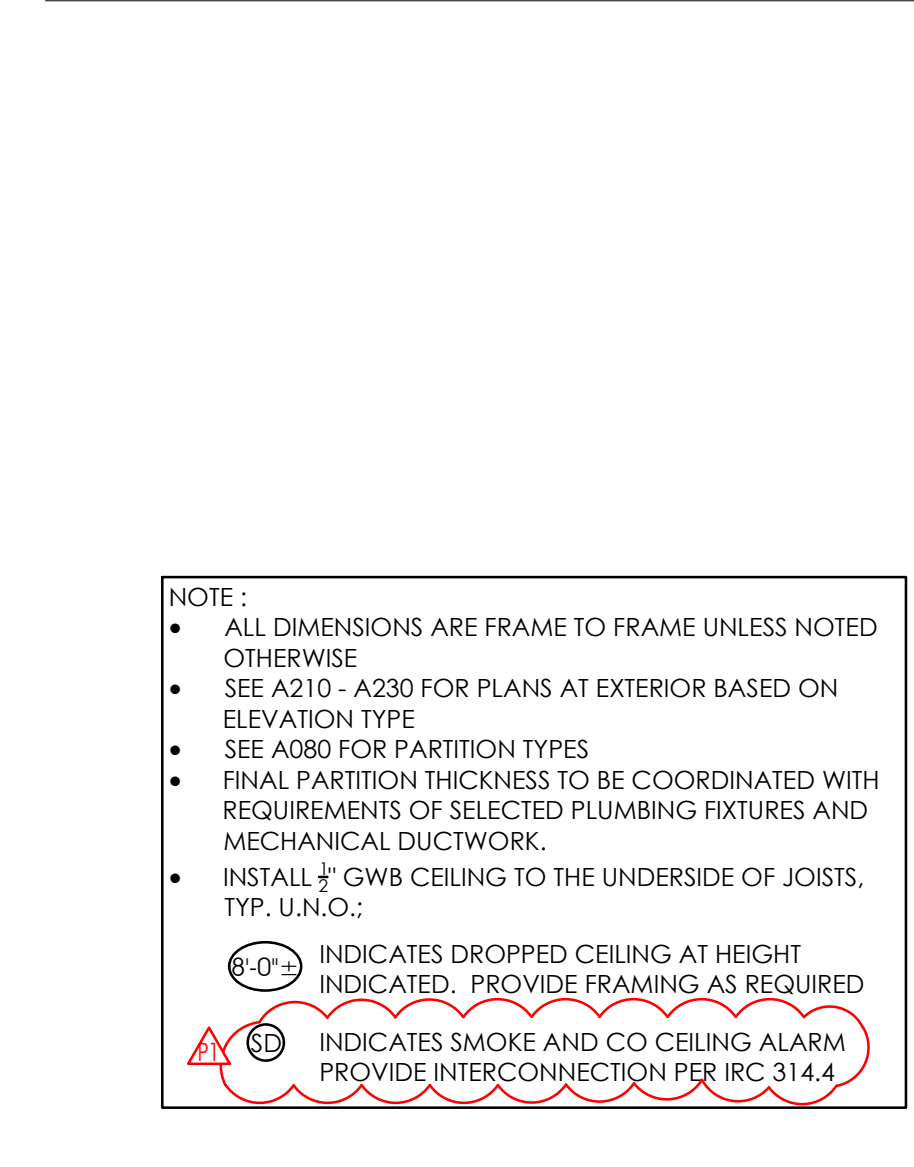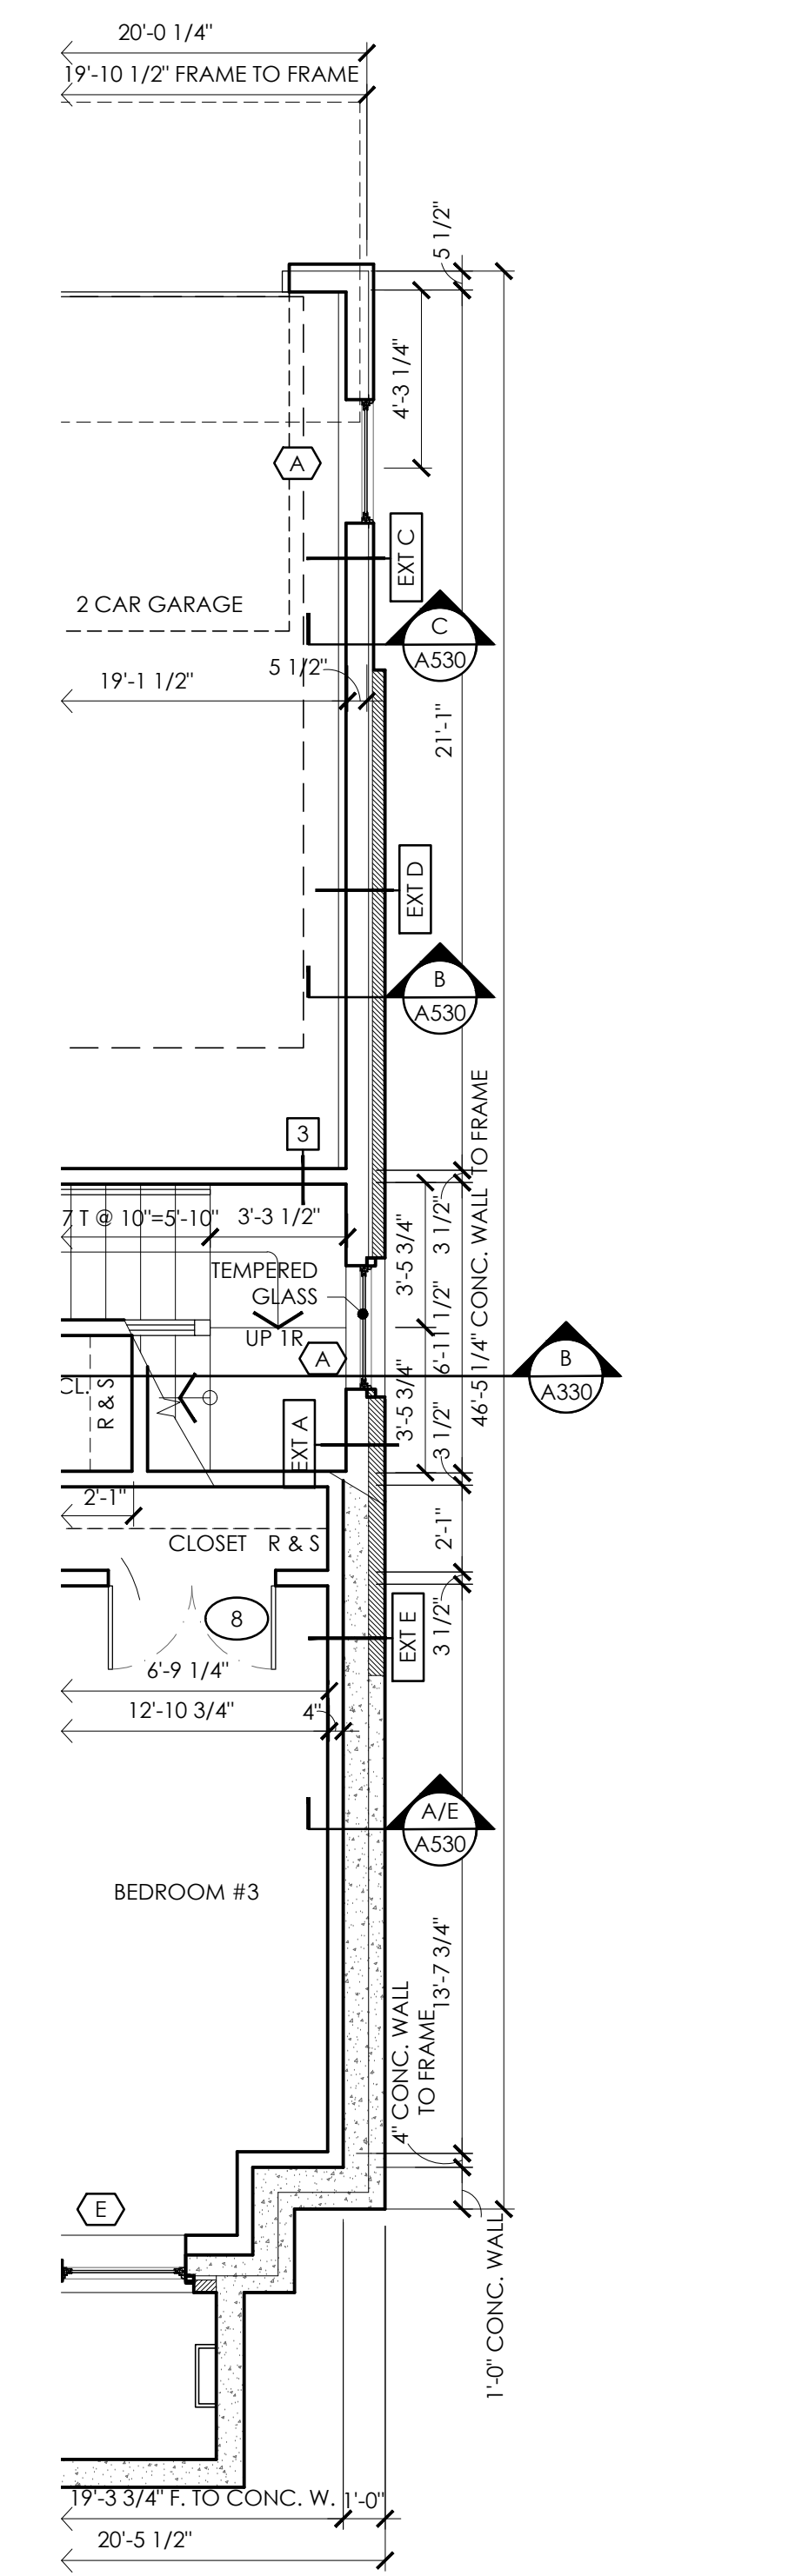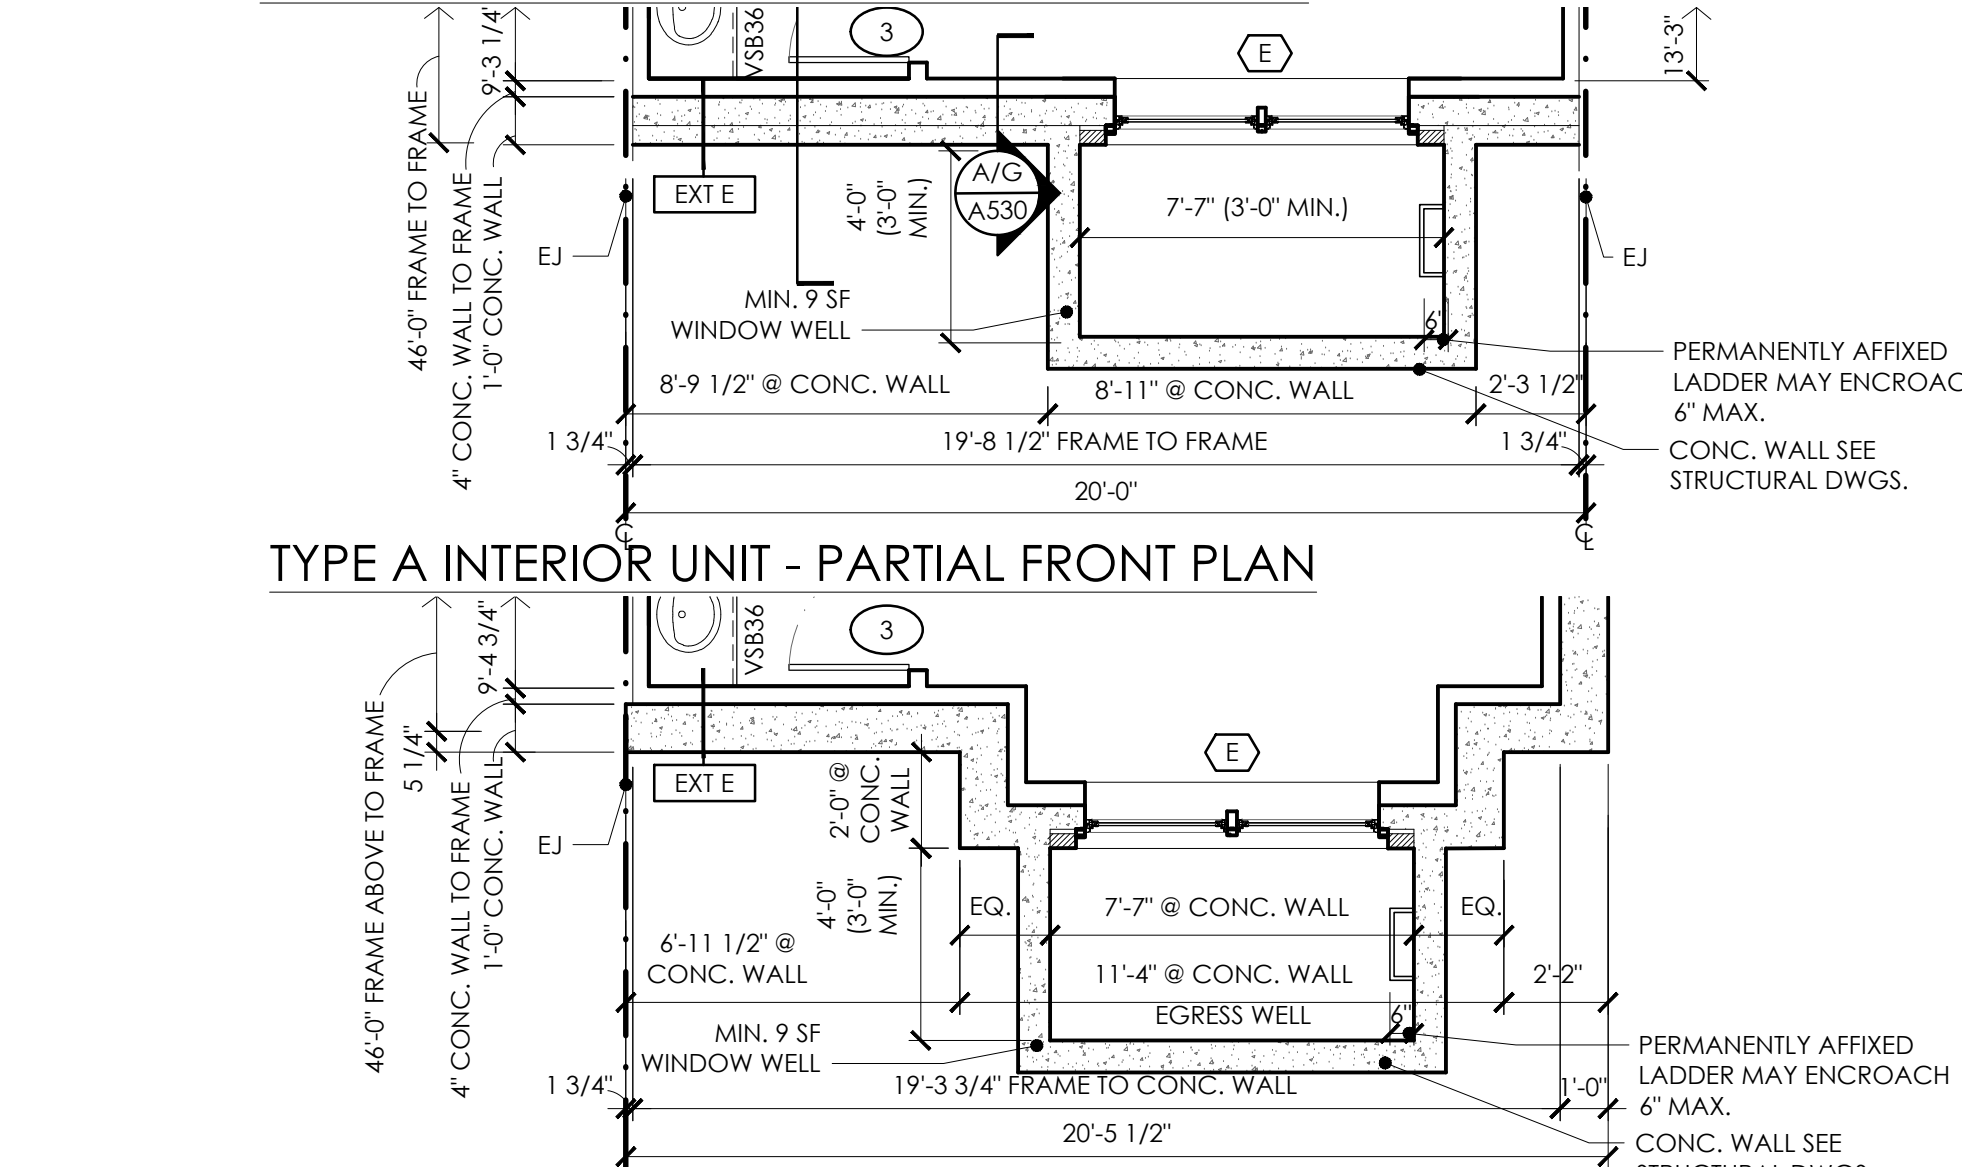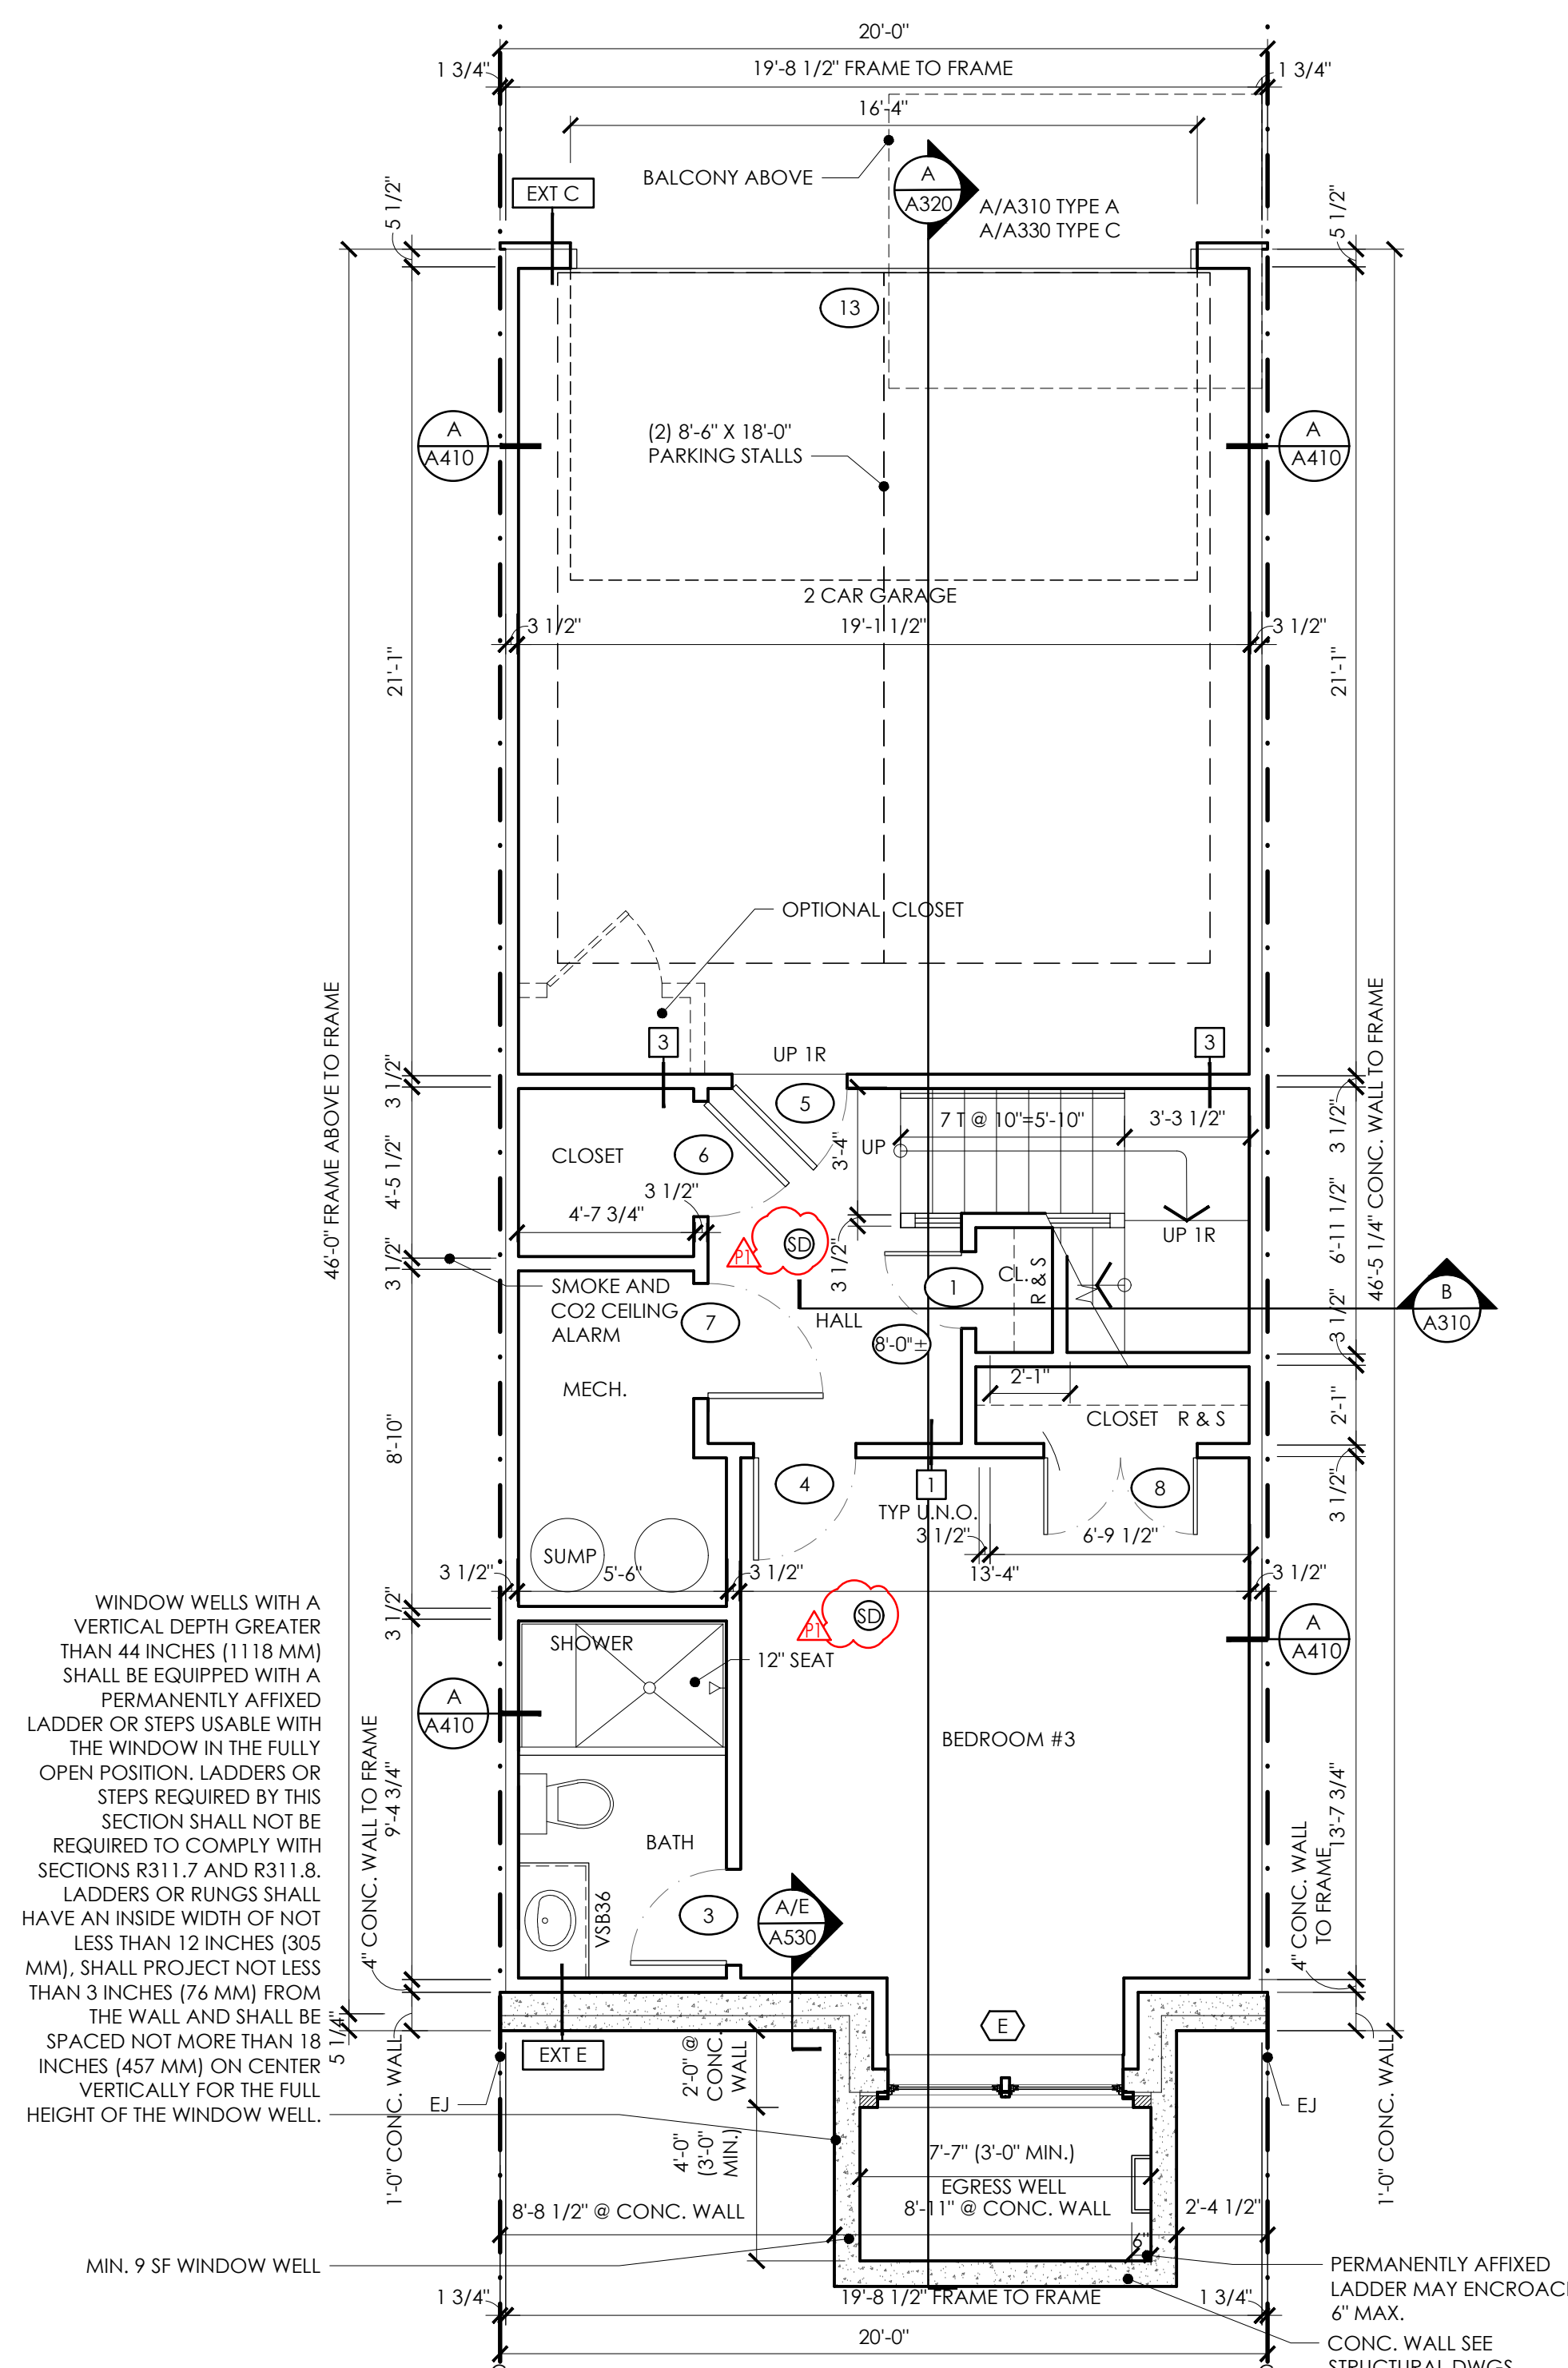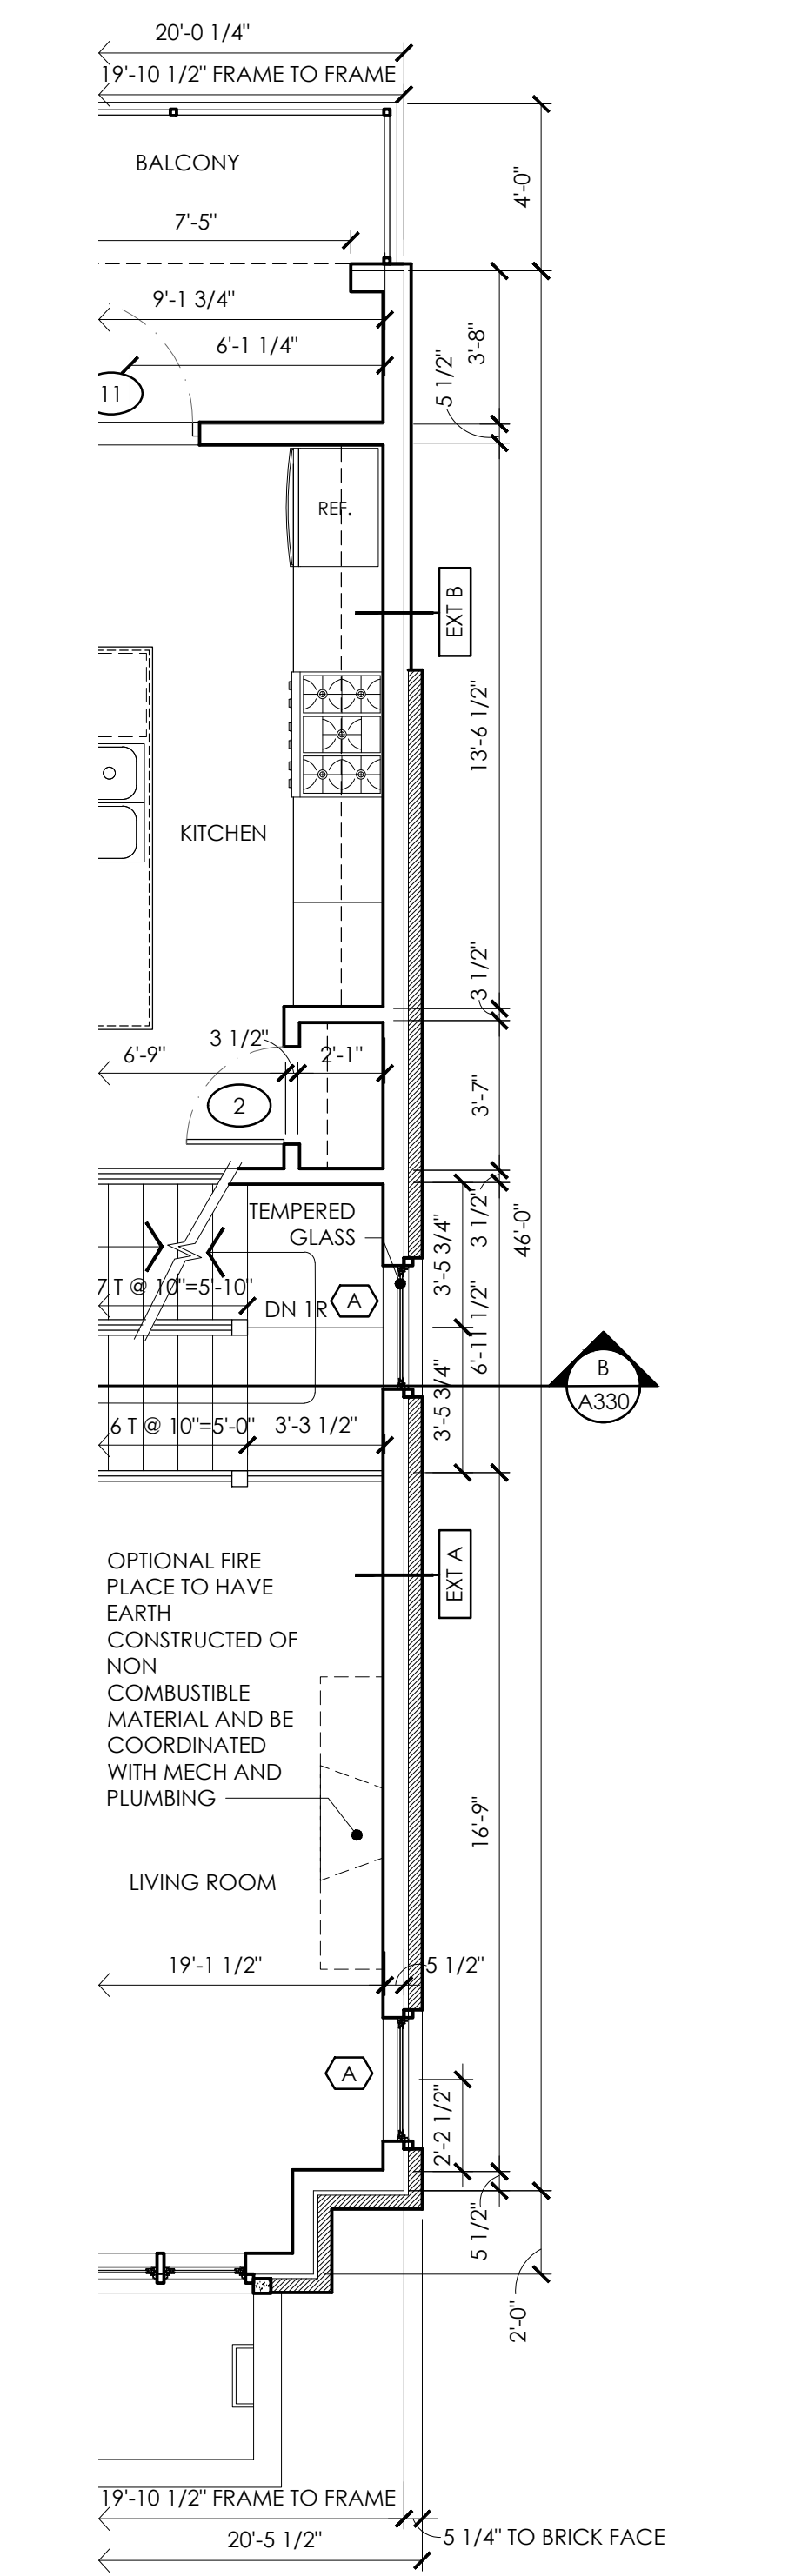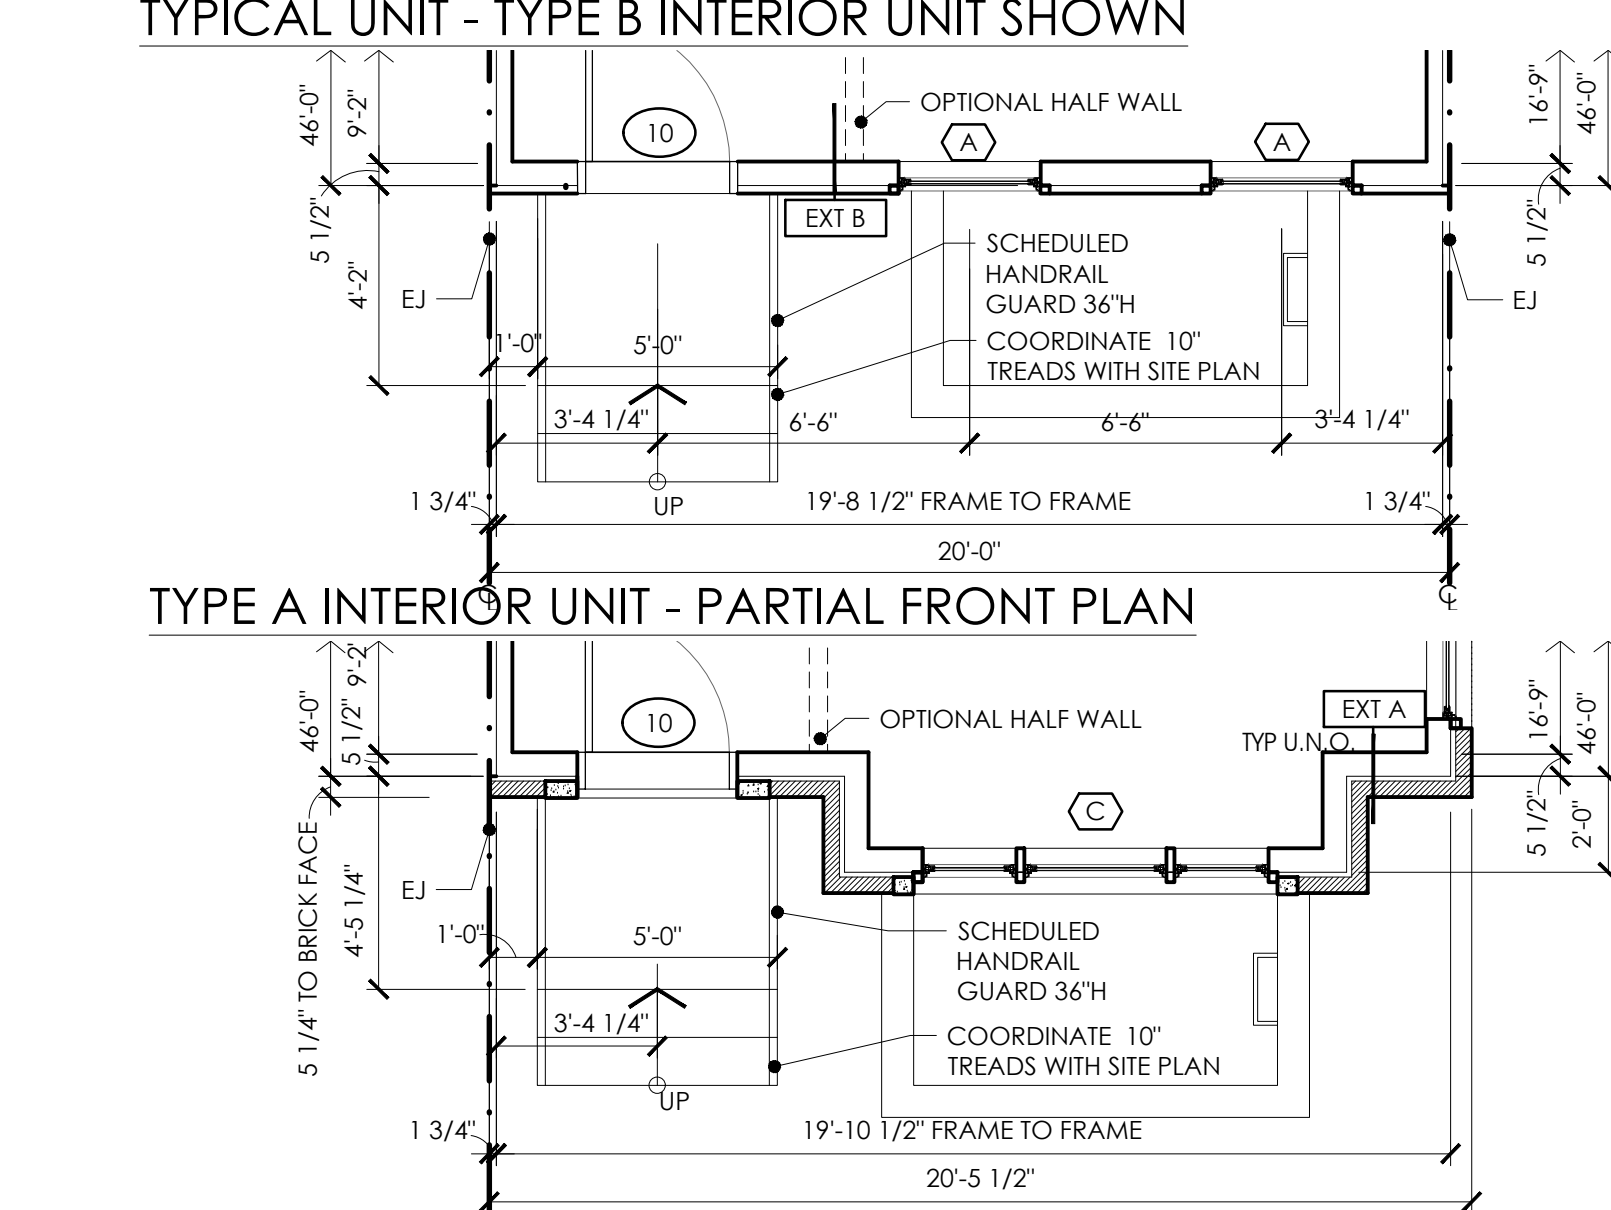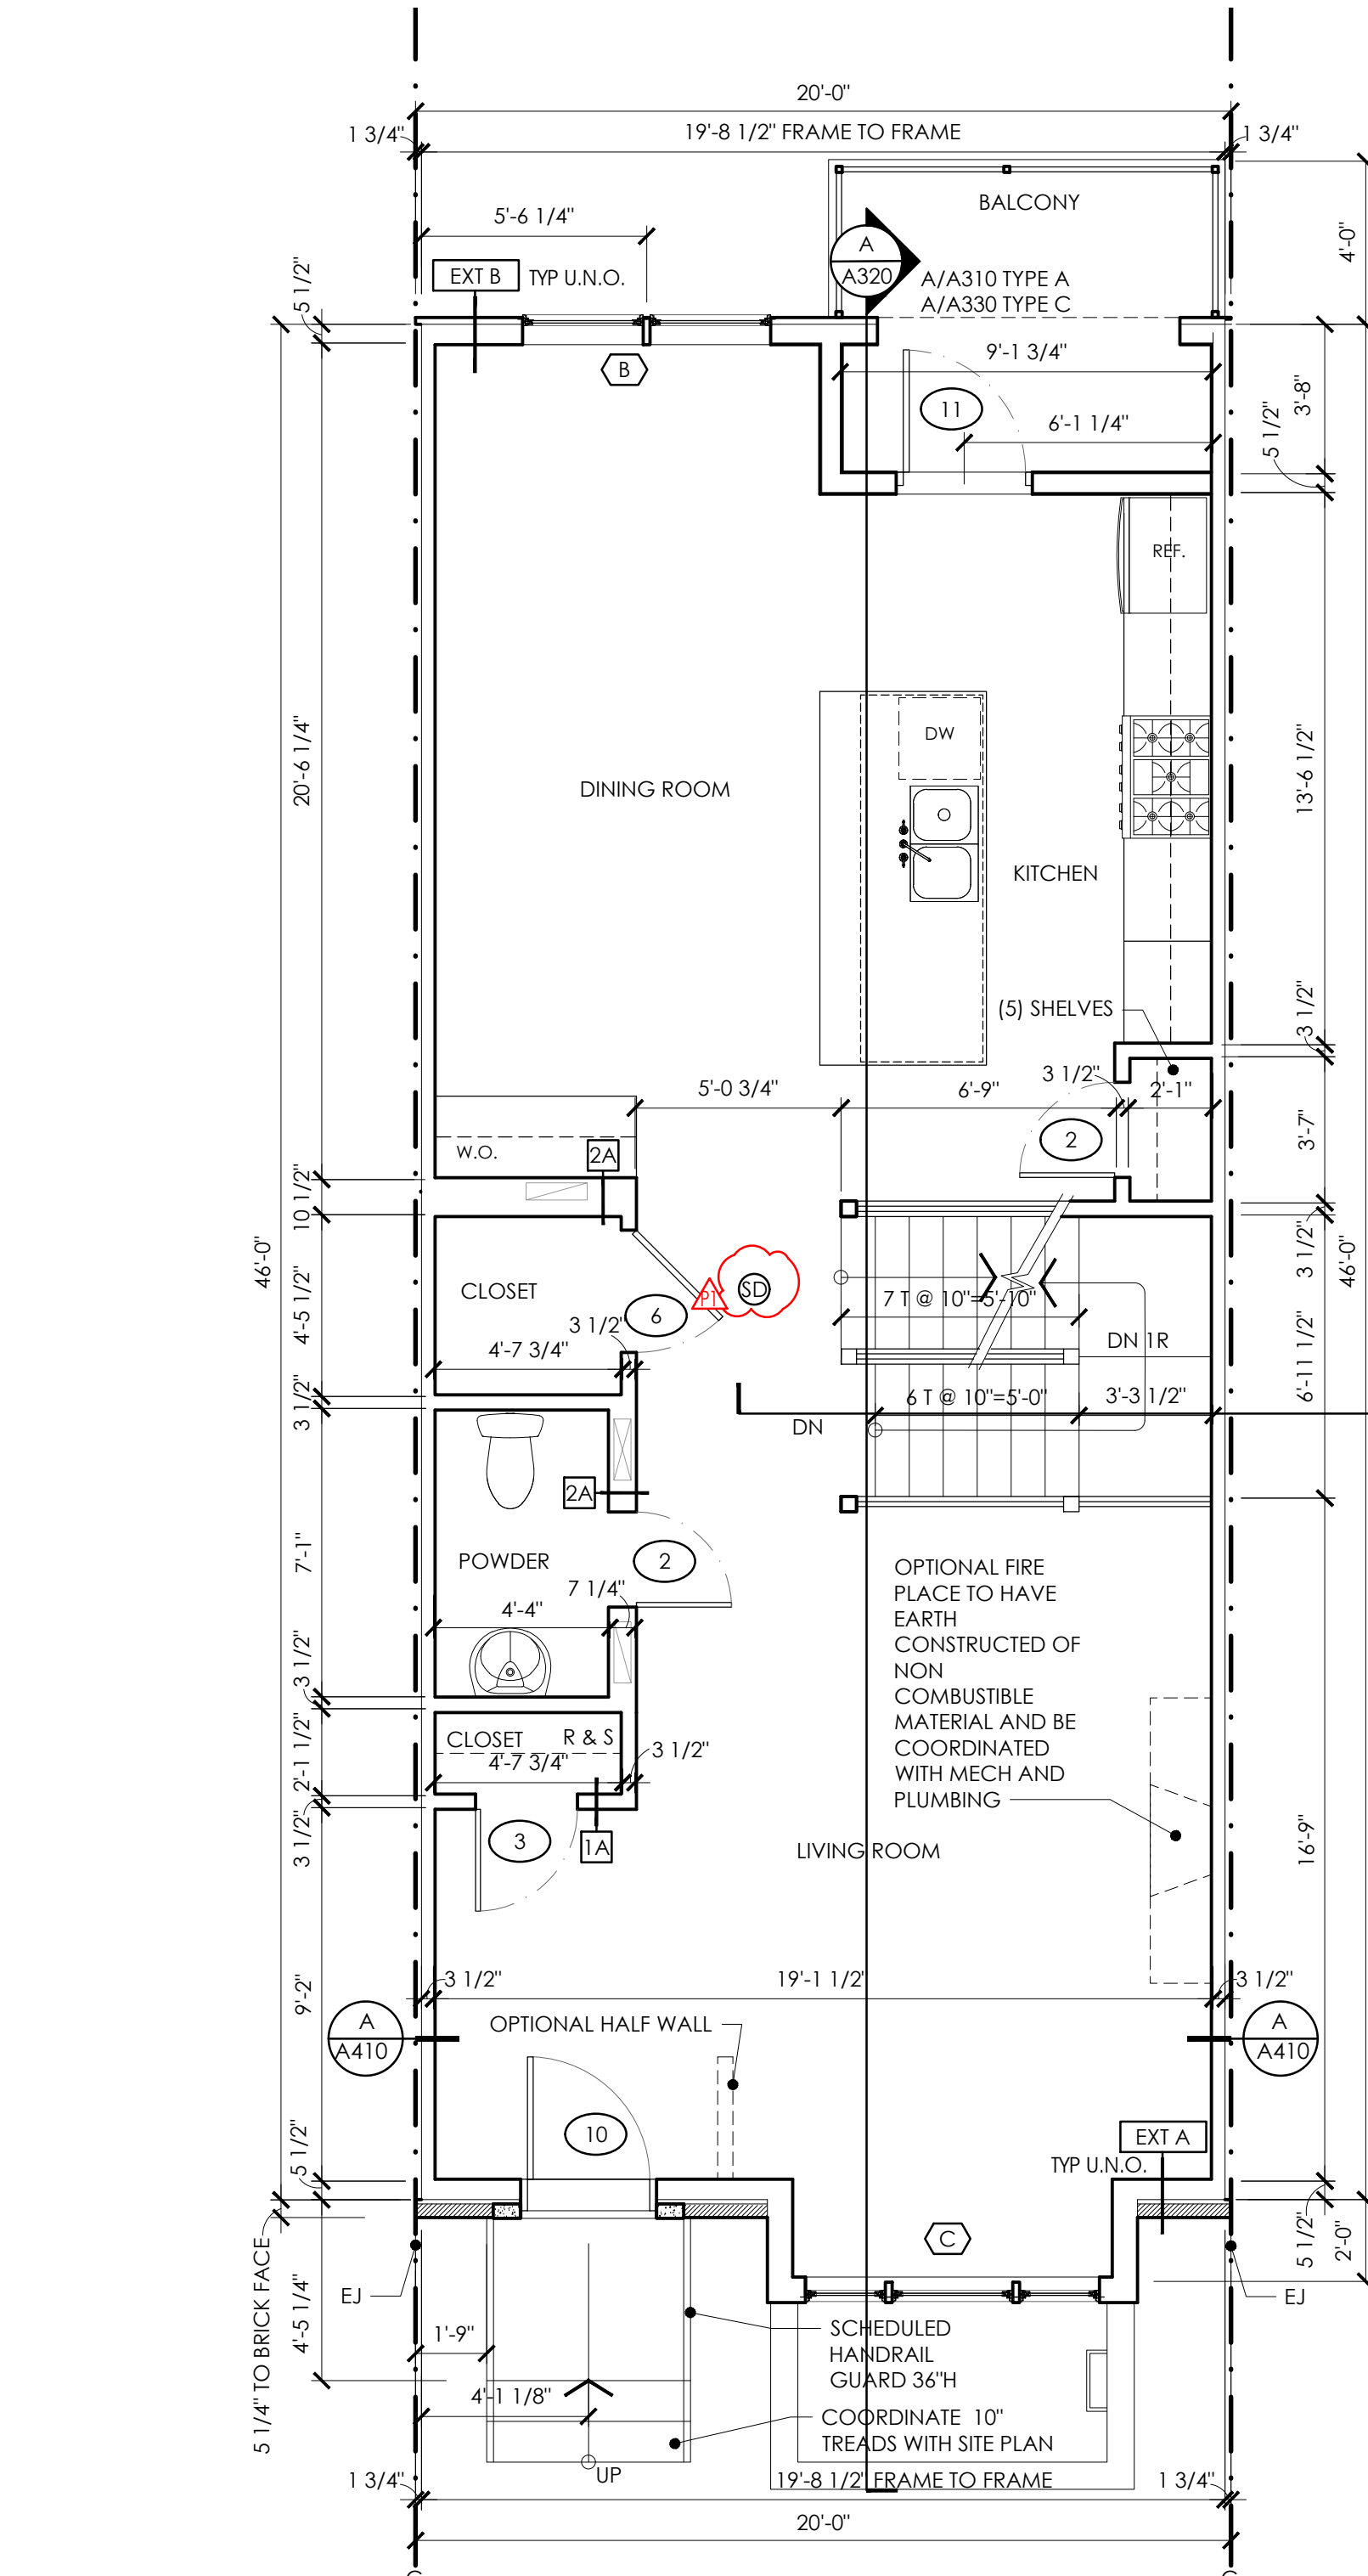

NOTE:

- ALL DIMENSIONS ARE FRAME TO FRAME UNLESS NOTED OTHERWISE
- SEE A210 - A230 FOR PLANS AT EXTERIOR BASED ON ELEVATION TYPE
- SEE A800 FOR PARTITION TYPES
- FINAL PARTITION THICKNESS TO BE COORDINATED WITH REQUIREMENTS OF SELECTED PLUMBING FIXTURES AND MECHANICAL DUCTWORK.
- INSTALL 3/4" GWB CEILING TO THE UNDERSIDE OF JOISTS TR. U.N.G.;

 INDICATES DROPPED CEILING AT HEIGHT INDICATED. PROVIDE FRAMING AS REQUIRED

 INDICATES SMOKE AND CO CEILING ALARM PROVIDE INTERCONNECTION PER IRC 314.4

GARAGE LEVEL PLAN